

SCOPE OF WORK

THE BASE SCOPE OF WORK FOR THIS PROJECT SHALL CONSIST OF THE DEMOLITION AND REPLACEMENT OF THE EXISTING WIRELESS FIRE ALARM MONITORING NETWORK AT THE MARYLAND ZOO IN BALTIMORE (MZB) WITH A FIBER OPTIC-BASED NETWORK. ADDITIONALLY, A COMPLETE NOTIFIER ONYX SERIES FIRE ALARM MONITORING NETWORK THAT INCLUDES FIRE ALARM CONTROL UNITS (FACUs, OR FIRE ALARM NODES) AND GRAPHIC USER INTERFACES (GUIs) SHALL BE INSTALLED AT MZB.

UPON COMMISSIONING AND FINAL ACCEPTANCE OF THE NEW NOTIFIER SYSTEM, THE CONTRACTOR SHALL REMOVE ALL EXISTING KELTRON HEAD-END EQUIPMENT LOCATED AT THE MANSION HOUSE AND ALL KELTRON TRANSMITTERS SPECIFIED IN TABLE 1 ON SHEET FA002. OUT OF SERVICE KELTRON EQUIPMENT SHALL BE TURNED OVER TO THE MZB.

IF BID OPTION 1 IN SPECIFICATION SECTION 00400 IS EXERCISED, THE CONTRACTOR SHALL REPLACE ALL EXISTING ADDRESSABLE INITIATING DEVICES, MODULES AND NOTIFICATION APPLIANCES ONE FOR ONE WITH NOTIFIER NFS-320 / NFS2-640 COMPATIBLE DEVICES/APPLIANCES.

IF BID OPTION 2 IN SPECIFICATION SECTION 00400 IS EXERCISED, THE CONTRACTOR SHALL PROVIDE AN ENTERPRISE-WIDE LICENSE OF DRMNS SERVER SOFTWARE AND INSTALL ON THE FIRE ALARM GRAPHIC USER INTERFACE.

IF BID OPTION 3 IN SPECIFICATION SECTION 00400 IS EXERCISED, THE CONTRACTOR SHALL PROVIDE DRMNS FIRE ALARM CONTROL PANEL INTEGRATION WITH THE NOTIFIER SYSTEM.

IF BID OPTION 4 IN SPECIFICATION SECTION 00400 IS EXERCISED, THE CONTRACTOR SHALL PROVIDE DRMNS TWO-WAY RADIO TEXT-TO-SPEECH (TTS) INTEGRATION AND CONFIGURATION WITH THE MOTOROLA CM300 RADIO SYSTEM.

IF BID OPTION 5 IN SPECIFICATION SECTION 00400 IS EXERCISED, THE CONTRACTOR SHALL PROVIDE NOTIFIER DVC'S, HYPERSPIKE OUTDOOR HIGH-POWER SPEAKER ARRAYS AND WIDE AREA MASS NOTIFICATION SYSTEM.

APPLICABLE CODES

- BUILDING, FIRE AND RELATED CODES OF BALTIMORE CITY, 2020 EDITION.
- INTERNATIONAL BUILDING CODE (IBC), 2018 EDITION.
- INTERNATIONAL FIRE CODE (IFC), 2019 EDITION.
- NFPA 70, NATIONAL ELECTRICAL CODE, 2017 EDITION.
- NFPA 72, NATIONAL FIRE ALARM AND SIGNALING CODE, 2016 EDITION.
- NFPA 110, STANDARD FOR EMERGENCY AND STANDBY POWER SYSTEMS, 2016 EDITION.
- NFPA 150, FIRE AND LIFE SAFETY IN ANIMAL HOUSING FACILITIES, 2016 EDITION.
- NFPA 731, STANDARDED FOR THE INSTALLATION OF ELECTRONIC PREMISES SECURITY SYSTEMS, 2017 EDITION.
- THE LATEST PUBLISHED EDITION OF THE EQUIPMENT MANUFACTURERS' PRODUCT DATASHEETS, TECHNICAL SPECIFICATIONS, INSTALLATION INSTRUCTIONS AND WIRING GUIDELINES.

GENERAL NOTES

- THE DRAWINGS ARE DIAGRAMMATIC IN NATURE AND ARE NOT INTENDED TO BE USED FOR EXACT MEASURE OR FABRICATION. ALL FIRE ALARM CIRCUIT ROUTING SHOWN IS CONCEPTUAL. CONTRACTOR IS RESPONSIBLE FOR PROVIDING A LAYOUT AND INSTALLING THE NEW FIRE ALARM SYSTEM IN ACCORDANCE WITH THE CONTRACT REQUIREMENTS AND APPLICABLE CODES.
- FINAL DEVICE LOCATIONS MUST MEET THE REQUIREMENTS OF THE APPLICABLE CODES, SPECIFICATION SECTION 283111 AND BE DOCUMENTED ON AS-BUILT DRAWINGS.
- NOT ALL DEVICES NEEDED FOR A COMPLETE AND WORKING FIRE ALARM SYSTEM ARE SHOWN ON THESE CONCEPT DRAWINGS. PROVIDE EQUIPMENT AS NECESSARY FOR A FULLY OPERATIONAL SYSTEM.
- EXISTING FIRE ALARM DEVICE COUNTS INDICATED IN TABLE 2 ON SHEET FA002 ARE ESTIMATES ONLY. EXACT NUMBER OF DEVICES TO BE REPLACED SHALL BE CONFIRMED BY THE CONTRACTOR. THE CONTRACTOR BID SHALL INCLUDE A COMPLETE PER UNIT COST FOR EACH SPECIFIC DEVICE IN THE EVENT MORE OR LESS DEVICES ARE REQUIRED.
- PROVIDE ALL SOFTWARE, SUBSCRIPTIONS, LICENSES, COMPONENTS, EQUIPMENT AND WIRING NEEDED FOR A COMPLETE AND WORKING DRMNS SYSTEM IN ACCORDANCE WITH THE APPLICABLE BID OPTION IN SPECIFICATION SECTION 00400 THAT IS EXERCISED.

DEMOLITION NOTES

- ALL EXISTING SYSTEMS AND EQUIPMENT BEING REPLACED OR THEIR OPERATION ABANDONED SHALL BE REMOVED IMMEDIATELY AFTER THE NEW FIRE ALARM SYSTEM IS ACCEPTED BY THE OWNER.
- ALL RESTORATION, PATCHING, PAINTING AND FIRESTOPPING OF CEILINGS, WALLS, AND FLOORS DAMAGED BY THE INSTALLATION OR DEMOLITION OF THIS FIRE ALARM SYSTEM SHALL BE COVERED IN THE SCOPE OF THIS WORK.
- EXISTING CONDUIT EMBEDDED IN MASONRY WALLS SHALL HAVE ALL CONDUCTORS REMOVED AND BE ABANDONED IN PLACE. EXISTING EXPOSED CONDUIT AND CONDUIT ABOVE ACCESSIBLE CEILINGS SHALL BE REMOVED.
- EXISTING DEVICE BACK BOXES INSTALLED RECESSED IN MASONRY WALLS SHALL BE ABANDONED IN PLACE AND PROVIDED WITH STAINLESS STEEL BLANK COVER PLATES.
- WHERE EXISTING DUCT SMOKE DETECTORS ARE REMOVED, PATCH AND RE-INSULATE DUCTWORK TO MATCH EXISTING. COORDINATE THE REMOVAL OF ALL DUCT SMOKE DETECTORS WITH OWNERS FACILITIES SERVICE PERSONNEL.
- CONTRACTOR SHALL REPLACE ALL CEILING TILES IN WHICH AN EXISTING FIRE ALARM DEVICE WAS REMOVED. THE NEW CEILING TILES SHALL MATCH THE EXISTING.
- ALL MATERIALS, DEVICES AND EQUIPMENT REMOVED SHALL BE PROPERLY DISPOSED OF FOLLOWING DEMOLITION.
- EXISTING DEVICE BACK BOXES INSTALLED RECESSED IN GYPSUM WALLBOARD OR PLASTER COVERED WALLS SHALL BE REMOVED. PATCH AND FINISH HOLE TO MATCH SURROUNDING SURFACES.
- EXISTING DEVICE BACK BOXES INSTALLED RECESSED IN WALLS WITH DECORATIVE WALL COVERINGS SHALL BE ABANDONED IN PLACE AND PROVIDED WITH A STAINLESS STEEL COVER PLATE.

SHEET NOTES

1	PROVIDE A NEW NOTIFIER ONYX WORKS GRAPHIC USER INTERFACE.
2	PROVIDE A NEW NOTIFIER NFS2-640 FIRE ALARM CONTROL UNIT AT THIS LOCATION. CONNECT THE FACU TO THE FIBER OPTIC NETWORK.
3	EXISTING NOTIFIER NFS-320 FIRE ALARM CONTROL UNIT TO REMAIN. CONNECT THE FACU TO THE FIBER OPTIC NETWORK.
4	EXISTING NOTIFIER NFS2-640 FIRE ALARM CONTROL UNIT TO REMAIN. CONNECT THE FACU TO THE FIBER OPTIC NETWORK.
5	EXISTING NOTIFIER NFS2-640 FIRE ALARM CONTROL UNIT TO BE RE-LOCATED TO THE MECHANICAL SHED. CONNECT THE FACU TO THE FIBER OPTIC NETWORK.
6	EXISTING NOTIFIER NFW2-100 FIRE ALARM CONTROL UNIT TO BE DEMOLISHED.
7	EXISTING NOTIFIER NFS-320 FIRE ALARM CONTROL UNIT TO BE DEMOLISHED.
8	EXISTING NOTIFIER NFS2-640 FIRE ALARM CONTROL UNIT TO BE DEMOLISHED.
9	EXISTING FIRE-LITE MS-9600 UDLs(E) FIRE ALARM CONTROL UNIT TO BE DEMOLISHED.
10	EXISTING VOICE EVACUATION ALARM PANEL TO REMAIN. INTERFACE WITH FACU IN BUILDING.
11	EXISTING VOICE EVACUATION ALARM PANEL TO REMAIN. INTERFACE WITH FACU IN MAINTENANCE AND COMMISSARY.
12	EXISTING VOICE EVACUATION ALARM PANEL TO REMAIN. INTERFACE WITH FACU IN MECHANICAL SHED.
13	EXISTING VOICE EVACUATION ALARM PANEL TO REMAIN. INTERFACE WITH FACU IN MEETING BARN.
14	EXISTING VOICE EVACUATION ALARM PANEL TO REMAIN. INTERFACE WITH FACU IN POLAR BEAR HOLDING.
15	EXISTING VOICE EVACUATION ALARM PANEL TO REMAIN. INTERFACE WITH FACU IN POLAR BEAR TRAILER.
16	EXISTING VOICE EVACUATION ALARM PANEL TO REMAIN. INTERFACE WITH FACU IN RHINO/ZEBRA BARN.
17	EXISTING VOICE EVACUATION ALARM PANEL TO REMAIN. INTERFACE WITH FACU IN RESTROOMS & FORMERLY SIDETRACK CAFÉ.
18	PROVIDE NEW SMOKE DETECTION THROUGHOUT THE BUILDING. DESIGN AND LAYOUT OF THE SYSTEM TO BE REVIEWED AND COMPLETED BY THE CONTRACTOR.
19	PROVIDE NEW HEAT DETECTION THROUGHOUT THE BUILDING. DESIGN AND LAYOUT OF THE SYSTEM TO BE REVIEWED AND COMPLETED BY THE CONTRACTOR.
20	PROVIDE NEW DUCT SMOKE DETECTION THROUGHOUT THE BUILDING. DESIGN AND LAYOUT OF THE SYSTEM TO BE REVIEWED AND COMPLETED BY THE CONTRACTOR.
21	EXISTING FIRE ALARM SYSTEM COMPONENTS (DEVICES, APPLIANCES, ETC.) TO REMAIN IN THIS BUILDING. INTERFACE WITH FACU IN THE BUILDING.
22	EXISTING DEVICES TO BE DEMOLISHED AND REPLACED IN KIND. NEW DEVICES FED FROM FACU IN BUILDING.
23	EXISTING DEVICES TO BE DEMOLISHED AND REPLACED IN KIND. NEW DEVICES FED FROM FACU IN AFRICA BARN.
24	EXISTING DEVICES TO BE DEMOLISHED AND REPLACED IN KIND. NEW DEVICES TO BE FED FROM FACU IN BIRD BARN/OLD SITATUNGA.
25	EXISTING DEVICES TO BE DEMOLISHED AND REPLACED IN KIND. NEW DEVICES TO BE FED FROM FACU IN CHIMPANZEE FOREST.
26	EXISTING DEVICES TO BE DEMOLISHED AND REPLACED IN KIND. NEW DEVICES FED FROM FACU IN CONSTRUCTION TRAILER.
27	EXISTING DEVICES TO BE DEMOLISHED AND REPLACED IN KIND. NEW DEVICES FED FROM FACU IN CRANE BARN.
28	EXISTING DEVICES TO BE DEMOLISHED AND REPLACED IN KIND. NEW DEVICES TO BE FED FROM FACU IN ELEPHANT HOUSE.
29	EXISTING DEVICES TO BE DEMOLISHED AND REPLACED IN KIND. NEW DEVICES FED FROM FACU IN MAINTENANCE AND COMMISSARY.
30	EXISTING DEVICES TO BE DEMOLISHED AND REPLACED IN KIND. NEW DEVICES TO BE FED FROM FACU IN MANSION HOUSE.
31	EXISTING DEVICES TO BE DEMOLISHED AND REPLACED IN KIND. NEW DEVICES FED FROM FACU IN MECHANICAL SHED.
32	EXISTING DEVICES TO BE DEMOLISHED AND REPLACED IN KIND. NEW DEVICES FED FROM FACU IN MEETING BARN.
33	EXISTING DEVICES TO BE DEMOLISHED AND REPLACED IN KIND. NEW DEVICES TO BE FED FROM FACU IN OTTER/BOBCAT HOLDING.
34	EXISTING DEVICES TO BE DEMOLISHED AND REPLACED IN KIND. NEW DEVICES FED FROM FACU IN PENGUIN COAST INTERPRETIVE CENTER.
35	EXISTING DEVICES TO BE DEMOLISHED AND REPLACED IN KIND. NEW DEVICES FED FROM FACU IN POLAR BEAR HOLDING.
36	EXISTING DEVICES TO BE DEMOLISHED AND REPLACED IN KIND. NEW DEVICES TO BE FED FROM FACU IN POLAR BEAR TRAILER.
37	EXISTING DEVICES TO BE DEMOLISHED AND REPLACED IN KIND. NEW DEVICES FED FROM FACU IN RHINO/ZEBRA BARN.
38	EXISTING DEVICES TO BE DEMOLISHED AND REPLACED IN KIND. NEW DEVICES FED FROM FACU IN RESTROOMS & FORMERLY SIDETRACK CAFÉ.
39	EXISTING DEVICES TO BE DEMOLISHED AND REPLACED IN KIND. NEW DEVICES FED FROM FACU IN WILD THINGS GIFT SHOP.
40	DEMOLISH THE EXISTING BEAM DETECTION IN THE BUILDING.
41	DEMOLISH THE EXISTING YELLOW COLORED STROBE(S) FOR SNAKE BITE NOTIFICATION IN THIS LOCATION.
42	DEMOLISH THE EXISTING GREEN COLORED STROBE(S) FOR ANIMAL ESCAPE NOTIFICATION IN THIS LOCATION.
43	DEMOLISH THE EXISTING BLUE COLORED STROBE(S) FOR ANIMAL HABITAT OZONE LEVEL NOTIFICATION IN THIS LOCATION.
44	PROVIDE A NEW VERY EARLY WARNING AIR ASPIRATING SMOKE DETECTION SYSTEM IN THE BUILDING. PROVIDE ALL COMPONENTS (HEAD-END, SAMPLING POINTS, PIPING, ETC.) NECESSARY FOR A FULLY FUNTIONAL SYSTEM. DESIGN AND LAYOUT OF THE SYSTEM TO BE REVIEWED AND COMPLETED BY THE CONTRACTOR.
45	EXISTING VERY EARLY WARNING SMOKE DETECTION SYSTEM (VESDA) TO REMAIN. INTERFACE VESDA SYSTEM WITH FACU.
46	EXISTING VERY EARLY WARNING SMOKE DETECTION SYSTEM (VESDA) TO REMAIN IN ZEBRA HOLDING. INTERFACE VESDA WITH FACU.
47	EXISTING VERY EARLY WARNING SMOKE DETECTION SYSTEM (FAAST) TO BE DEMOLISHED IN RHINO HOLDING. PROVIDE A NEW VERY EARLY WARNING AIR ASPIRATING SMOKE DETECTION SYSTEM (VESDA) IN THIS AREA. PROVIDE ALL COMPONENTS (HEAD-END, SAMPLING POINTS, PIPING, ETC.) NECESSARY FOR A FULLY FUNTIONAL SYSTEM. DESIGN AND LAYOUT OF THE SYSTEM TO BE REVIEWED AND COMPLETED BY THE CONTRACTOR.
48	PROVIDE AN ENTERPRISE-WIDE LICENSE OF DRMNS SERVER SOFTWARE AND INSTALL ON THE FIRE ALARM GRAPHIC USER INTERFACE, IF BID OPTION 2 IN SPECIFICATION SECTION 00400 IS EXERCISED.
49	PROVIDE DRMNS FIRE ALARM CONTROL PANEL INTEGRATION WITH THE NOTIFIER SYSTEM, IF BID OPTION 3 IN SPECIFICATION SECTION 00400 IS EXERCISED.
50	PROVIDE DRMNS TWO-WAY RADIO TEXT-TO-SPEECH (TTS) INTEGRATION AND CONFIGURATION WITH THE MOTOROLA CM300 RADIO SYSTEM, IF BID OPTION 4 IN SPECIFICATION SECTION 00400 IS EXERCISED.
51	DEMOLISH THE EXISTING FIRE ALARM SYSTEM IN THE BUILDING. BUILDING TO NO LONGER BE INCLUDED ON THE FIRE ALARM NETWORK.
52	PROVIDE A STI STOPPER BUTTON AT THIS LOCATION FOR SNAKE BITE NOTIFICATION. MONITOR ACTIVATION OF THE BUTTON VIA FIRE ALARM MONITOR MODULE AND REPORT AS AN EMERGENCY/NON-FIRE ALARM INPUT.
53	PROVIDE A HYPERSPIKE OUTDOOR HIGH-POWER SPEAKER ARRAY SYSTEM AT THIS LOCATION, IF BID OPTION 5 IN SPECIFICATION SECTION 00400 IS EXERCISED. HIGH-POWER SPEAKER ARRAY TO BE MOUNTED ADJACENT TO SPECIFIED BUILDING VIA NEW POLE SIZED PER THE MANUFACTURERS REQUIREMENTS/RECOMMENDATIONS. PROVIDE NEMA 3R RATED JUNCTION BOX AND RACEWAY TO AMPLIFIER AND SUPERVISORY CIRCUIT IN THE BUILDING. INSTALL IN ACCORDANCE WITH MANUFACTURERS SPECIFICATIONS.
54	PROVIDE A NOTIFIER DIGITAL VOICE COMMAND (DVC) FOR INTEGRATION WITH WIDE AREA MASS NOTIFICATION SYSTEM AND NETWORK WITH NOTIFIER NETWORK, IF BID OPTION 5 IN SPECIFICATION SECTION 00400 IS EXERCISED.
55	PROVIDE A NOTIFIER DVC AND HYPERSPIKE AMPLIFIER TO SUPPLY AUDIO SIGNAL TO THE HIGH-POWER SPEAKER ARRAY ADJACENT TO THE BUILDING, IF BID OPTION 5 IN SPECIFICATION SECTION 00400 IS EXERCISED.
56	EXISTING SINGLE MODE FIBER IN BUILDING.
57	PROVIDE NEW SINGLE MODE FIBER IN BUILDING.
58	PULL SPECIFIED CABLES/CIRCUITS THROUGH EXISTING UNDERGROUND INFRASTRUCTURE. SPARE CAPACITY WITHIN EXISTING UNDERGROUND INFRASTRUCTURE HAS NOT BEEN FULLY VERIFIED. PROVIDE BID ALTERNATE PRICE FOR TRENCHING AND RUNNING UNDERGROUND IN SCHEDULE 80 RIGID PVC SHOULD IT BE DETERMINED THAT SPARE CAPACITY IS NOT AVAILABLE.
59	RUN CABLES/CIRCUITS SPECIFIED UNDERGROUND IN SCHEDULE 80 RIGID PVC CONDUIT.
60	RUN CABLES/CIRCUITS SPECIFIED ALONG FENCELINE IN SCHEDULE 80 RIGID PVC CONDUIT.
61	TRENCHING THROUGH ASPHALT REQUIRED AT THIS LOCATION.
62	TRENCHING THROUGH CONCRETE REQUIRED AT THIS LOCATION.
63	TRENCHING THROUGH GRAVEL REQUIRED AT THIS LOCATION.
64	TRENCHING THROUGH SOIL/LANDSCAPE REQUIRED AT THIS LOCATION.
65	EXTEND CABLES/CIRCUITS SPECIFIED BY TRENCHING AND RUNNING UNDERGROUND IN SCHEDULE 80 RIGID PVC CONDUIT. COORDINATE INSTALLATION OF THE APPROVED OPTION WITH THE MZB.

LEGEND

	FIRE ALARM CONTROL UNIT
	GRAPHIC USER INTERFACE
	DIGITAL VOICE COMMAND
	HYPERSPIKE OUTDOOR HIGH POWER SPEAKER ARRAY
	FIBER HANDHOLE
	FIBER POLE
	FIBER OPTIC CABLE
	LINETYPE INDICATES NEW
	LINETYPE INDICATES EXISTING TO REMAIN
	SLASH INDICATES TO BE DEMOLISHED

CIRCUIT TAG LEGEND

S	ADDRESSABLE SLC - CLASS B/STYLE 4 (NO. 18 AWG)
n	NOTIFICATION APPLIANCE CIRCUIT - CLASS B (NO. 14 AWG)
f	SINGLE MODE FIBER OPTIC CABLE

SHEET NOTES LEGEND

Building/Exhibit	Sheet Notes	Sheet
Africa Barn	3, 22, 42, 56	Sheet FA104/113
Africa Watering Hole LSS Building	37	Sheet FA108/117
Animal Medical Building	4, 10, 41, 42, 52, 53, 55, 56	Sheet FA102/111
Animal Trailer	26, 56	Sheet FA108/117
Antelope/Warthog Barn	8, 16, 37, 42, 56	Sheet FA108/117
Bait Shack	34, 56	Sheet FA103/112
Bat Cava/Maryland Wilderness	6, 33, 41, 42, 52	Sheet FA103/112
Bird Barn/Old Sitatunga	4, 10, 22, 42, 57	Sheet FA103/112
Block Garage and Greenhouse	19, 29	Sheet FA108/118
Box Turtle Exhibit	6, 33	Sheet FA103/112
Chester Holding	6, 23	Sheet FA104/113
Chimpanzee Forest	2, 9, 10, 42, 45, 56	Sheet FA104/113
Chimpanzee Forest Restrooms	6, 25, 56	Sheet FA108/117
Construction Trailer	4, 22, 42, 53, 55, 56	Sheet FA103/112
Cow Barn	8, 13, 32, 42	Sheet FA107/116
Crane Barn	4, 10, 22, 42, 56	Sheet FA103/112
Donkey Barn	8, 32, 42, 56	Sheet FA103/112
Eagle Exhibit (Old Artic Fox Holding)	6, 35, 42	Sheet FA108/117
Elephant House	4, 21, 42, 56	Sheet FA103/112
Embassy Penguin	34, 56	Sheet FA103/112
Flamingo Holding	18, 34	Sheet FA108/117
Frog Trailer	36, 56	Sheet FA104/113
Giraffe Feeding Station	6, 25, 42, 56	Sheet FA104/113
Giraffe House	5, 12, 31, 40, 42, 44, 56	Sheet FA108/118
Goat Barn	8, 13, 32, 42	Sheet FA103/112
Grant Barn	8, 39, 56	Sheet FA108/117
Hay Barn	6, 19, 28, 42 (DEMOLISH EXISTING VESDA)	Sheet FA103/112
Heip Holding	8, 38, 41, 42, 52, 56	Sheet FA108/117
Keppert's Trailer (Polar/Food Service)	8, 15, 38, 42, 56	Sheet FA104/113
Leopard Holding	8, 20, 23, 42	Sheet FA104/113
Lion Holding	8, 12, 31, 42, 56	Sheet FA103/112
Lower Barn	8, 17, 38, 42	Sheet FA108/118
Maintenance and Commissary	1, 4, 11, 22, 42, 48, 54, 56	Sheet FA108/118
Maintenance Barn (Warehouse, Blue Storage Barn)	6, 29	Sheet FA107/116
Mammal House	5, 51	Sheet FA107/116
Mansion House	1, 4, 10, 22, 48, 49, 50, 54, 56	Sheet FA107/116
Maryland Building	4, 22, 56	Sheet FA103/112
Maryland Wilderness Sewage Lift Station	6, 38	Sheet FA103/112
Marsh Aviary LSS	6, 33	Sheet FA108/117
Meeting Barn	4, 10, 22, 42, 57	Sheet FA107/116
Membership Building	6, 21, 42, 56	Sheet FA108/117
Oasis Restrooms	6, 31, 56	Sheet FA103/112
Oasis Restaurant	31, 56	Sheet FA107/116
Old Elephant Building	6, 35, 42	Sheet FA103/112
Otter/Bobcat Holding	4, 10, 22, 42, 43, 56	Sheet FA103/112
Penguin Coast Interpretive Center	3, 22, 42, 56	Sheet FA103/112
Penguin Holding	7, 34, 42, 56	Sheet FA103/112
Formerly Pizza Depot (Sidetrack Café)	24	Sheet FA108/117
Polar Bear Holding	4, 10, 22, 42, 43, 56	Sheet FA103/112
Polar Bear LSS #1	8, 14, 35, 56	Sheet FA103/112
Polar Bear LSS #2	8, 14, 35, 56	Sheet FA108/117
Polar Bear Trailer	4, 22, 56	Sheet FA108/117
Records Trailer	26, 56	Sheet FA108/117
Restroom Trailer (adjacent to Keeper/HR)	36	Sheet FA108/117
Restroom Trailer (adjacent to Construction Trailer)	26	Sheet FA108/117
Rhino/Zebra Barn	4, 10, 22, 42, 46, 47, 56	Sheet FA108/118
Scheffer Restrooms	6, 39, 42	Sheet FA103/112
Formerly Sidetrack Café and Restrooms	4, 10, 22, 52, 53, 55, 56	Sheet FA107/116
Stone Shed	6, 51	Sheet FA108/118
Ticket Booths	6, 39, 56	Sheet FA108/118
Train Station	24, 56	Sheet FA103/112
Tree & Slide	6, 38, 52	Sheet FA103/112
Lundra Buggy	8, 14, 35, 42, 43	Sheet FA103/112
Wading Bird Building	6, 30	Sheet FA103/112
Whistle Stop	8, 38, 42, 56	Sheet FA103/112
Wild Things Gift Shop Building	4, 10, 20, 22, 53, 55, 56	Sheet FA108/118

MARYLAND ZOO



3610 Commerce Drive
Suite 817
Baltimore, MD 21227-1640
O: 410-737-8577 | F: 410-737-5588
www.jensenhughes.com

No.	Revision	Date

Graphics	Scale:	N.T.S.
Project Description	FIRE ALARM MONITORING NETWORK REPLACEMENT CONCEPTUAL DESIGN	
	Location: 1876 Mansion House Drive Baltimore, MD 21217	
	Design:	GM
	Drawn:	DG
Design	Review:	WW
	Date:	FEBRUARY 15, 2022
Drawing Title	GENERAL NOTES AND LEGEND	
Drawing No.	FA001	
	Sheet:	1 of 21


6. THE CONTRACTOR SHALL TEST EVERY EXISTING AND NEW BUILDING FIRE ALARM DEVICE, APPLIANCE, VOICE EVACUATION ALARM PANEL, VESDA SYSTEM, ETC. IN ACCORDANCE WITH THE MANUFACTURER'S LATEST PUBLISHED INFORMATION AND APPLICABLE NFPA STANDARDS AS REQUIRED BY THE CONTRACT DOCUMENTS.

1 EXISTING
SCALE: N.T.S.

2 FIRE AL
SCALE: N.T.S.



Sheet: 3 of 34

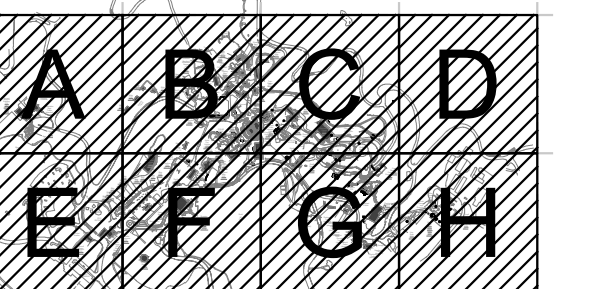[illegible]

Scale: Scale

0 150' 300'

1"=150'

**FIRE ALARM
MONITORING NETWORK
REPLACEMENT
CONCEPTUAL DESIGN**

Project	Location: 1876 Mansion House Drive Baltimore, MD 21217

Design	Design:	GM
	Drawn:	DG
	Review:	WW
	Date:	FEBRUARY 15, 2022

OVERALL NETWORK SITE PLAN

FA101

Sheet: 3 of 21

1

2

3

4

GENERAL NOTES

1. NO NEW WORK IN THE SCOPE OF THE PROJECT IN THIS AREA.

SEE SHEET FA104

SEE SHEET FA104

SEE SHEET FA109

SEE SHEET FA109

1

NETWORK SITE PLAN - AREA D
SCALE: 1" = 50'

SCALE: 1" = 50'

ISSUE FOR BID

MARYLAND ZOO




JENSEN HUGHES

Advancing the Science of Safety

3610 Commerce Drive
Suite 817
Baltimore, MD 21227-1640
O: 410-737-8677 | F: 410-737-8688
www.jensenhughes.com

[illegible]

Scale:	Scale
---------------	-------

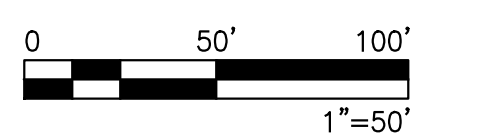

FIRE ALARM MONITORING NETWORK REPLACEMENT CONCEPTUAL DESIGN

Location: 1876 Mansion House Drive
Baltimore, MD 21217

Design:	GM
----------------	----

Drawn:	DG
---------------	----

Review:	WW
----------------	----

Date: FEBRUARY 15, 2022


**NETWORK SITE
PLAN - AREA D**

FA105

Sheet: 7 of 21

[illegible]

Scale: Scale

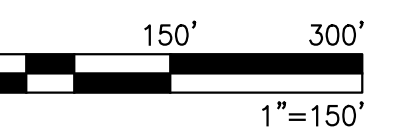

FIRE ALARM MONITORING NETWORK REPLACEMENT CONCEPTUAL DESIGN

Location: 1876 Mansion House Drive
Baltimore, MD 21217

Design: GM

Drawn: DG

review:	WW
date:	FEBRUARY 15, 2022


OVERALL NETWORK SITE PLAN

FA110

heet: 12 of 21



1 OVERALL NETWORK SITE PLAN
SCALE: 1" = 150'

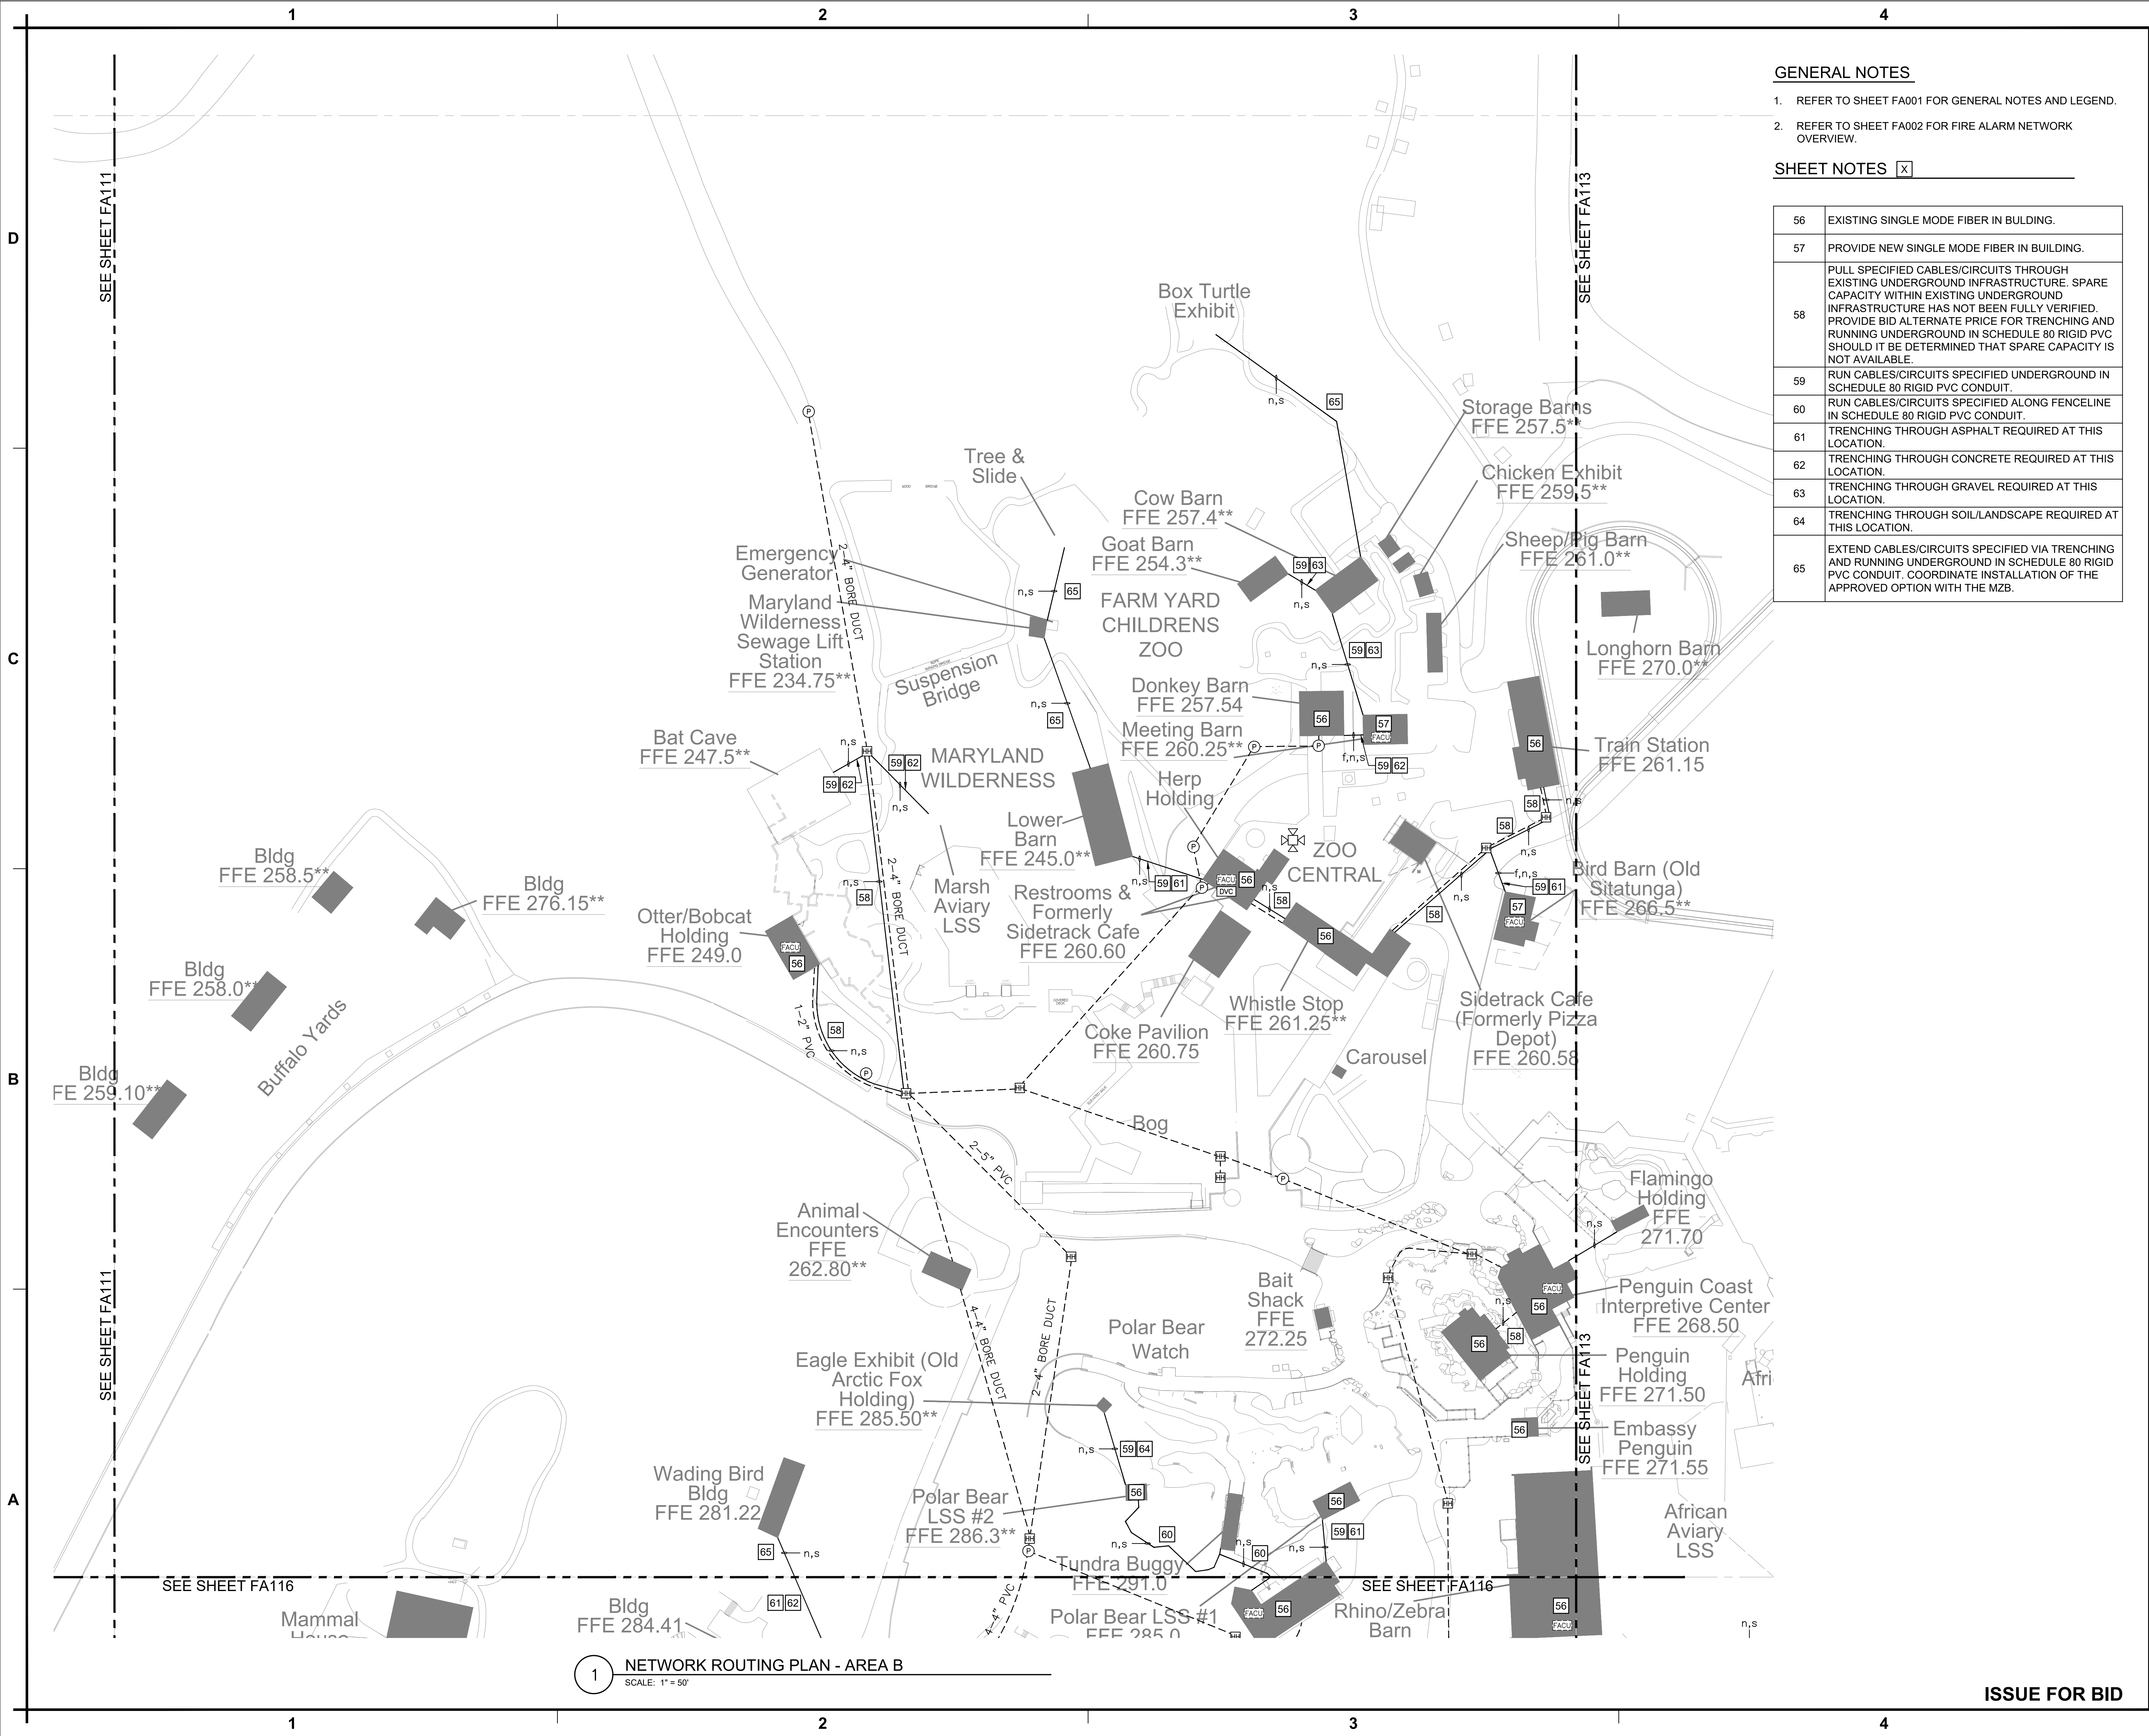

- GENERAL NOTES**
- REFER TO SHEET FA001 FOR GENERAL NOTES AND LEGEND.
 - REFER TO SHEET FA002 FOR FIRE ALARM NETWORK OVERVIEW.

SHEET NOTES ☒

56	EXISTING SINGLE MODE FIBER IN BUILDING.
57	PROVIDE NEW SINGLE MODE FIBER IN BUILDING.
58	PULL SPECIFIED CABLES/CIRCUITS THROUGH EXISTING UNDERGROUND INFRASTRUCTURE. SPARE CAPACITY WITHIN EXISTING UNDERGROUND INFRASTRUCTURE HAS NOT BEEN FULLY VERIFIED. PROVIDE BID ALTERNATE PRICE FOR TRENCHING AND RUNNING UNDERGROUND IN SCHEDULE 80 RIGID PVC SHOULD IT BE DETERMINED THAT SPARE CAPACITY IS NOT AVAILABLE.
59	RUN CABLES/CIRCUITS SPECIFIED UNDERGROUND IN SCHEDULE 80 RIGID PVC CONDUIT.
60	RUN CABLES/CIRCUITS SPECIFIED ALONG FENCELINE IN SCHEDULE 80 RIGID PVC CONDUIT.
61	TRENCHING THROUGH ASPHALT REQUIRED AT THIS LOCATION.
62	TRENCHING THROUGH CONCRETE REQUIRED AT THIS LOCATION.
63	TRENCHING THROUGH GRAVEL REQUIRED AT THIS LOCATION.
64	TRENCHING THROUGH SOIL/LANDSCAPE REQUIRED AT THIS LOCATION.
65	EXTEND CABLES/CIRCUITS SPECIFIED VIA TRENCHING AND RUNNING UNDERGROUND IN SCHEDULE 80 RIGID PVC CONDUIT. COORDINATE INSTALLATION OF THE APPROVED OPTION WITH THE MZB.

MARYLAND ZOO

JENSEN HUGHES
Advancing the Science of Safety

3610 Commerce Drive
Suite 817
Baltimore, MD 21227-1640
O: 410-737-8577 | F: 410-737-8588
www.jensenhughes.com

Scale: Scale

0 50' 100'
1"=50'

FIRE ALARM MONITORING NETWORK REPLACEMENT CONCEPTUAL DESIGN


Location: 1876 Mansion House Drive
Baltimore, MD 21217

Design: GM
Drawn: DG
Review: WW
Date: FEBRUARY 15, 2022

NETWORK ROUTING PLAN - AREA B

FA112


Sheet: 14 of 21

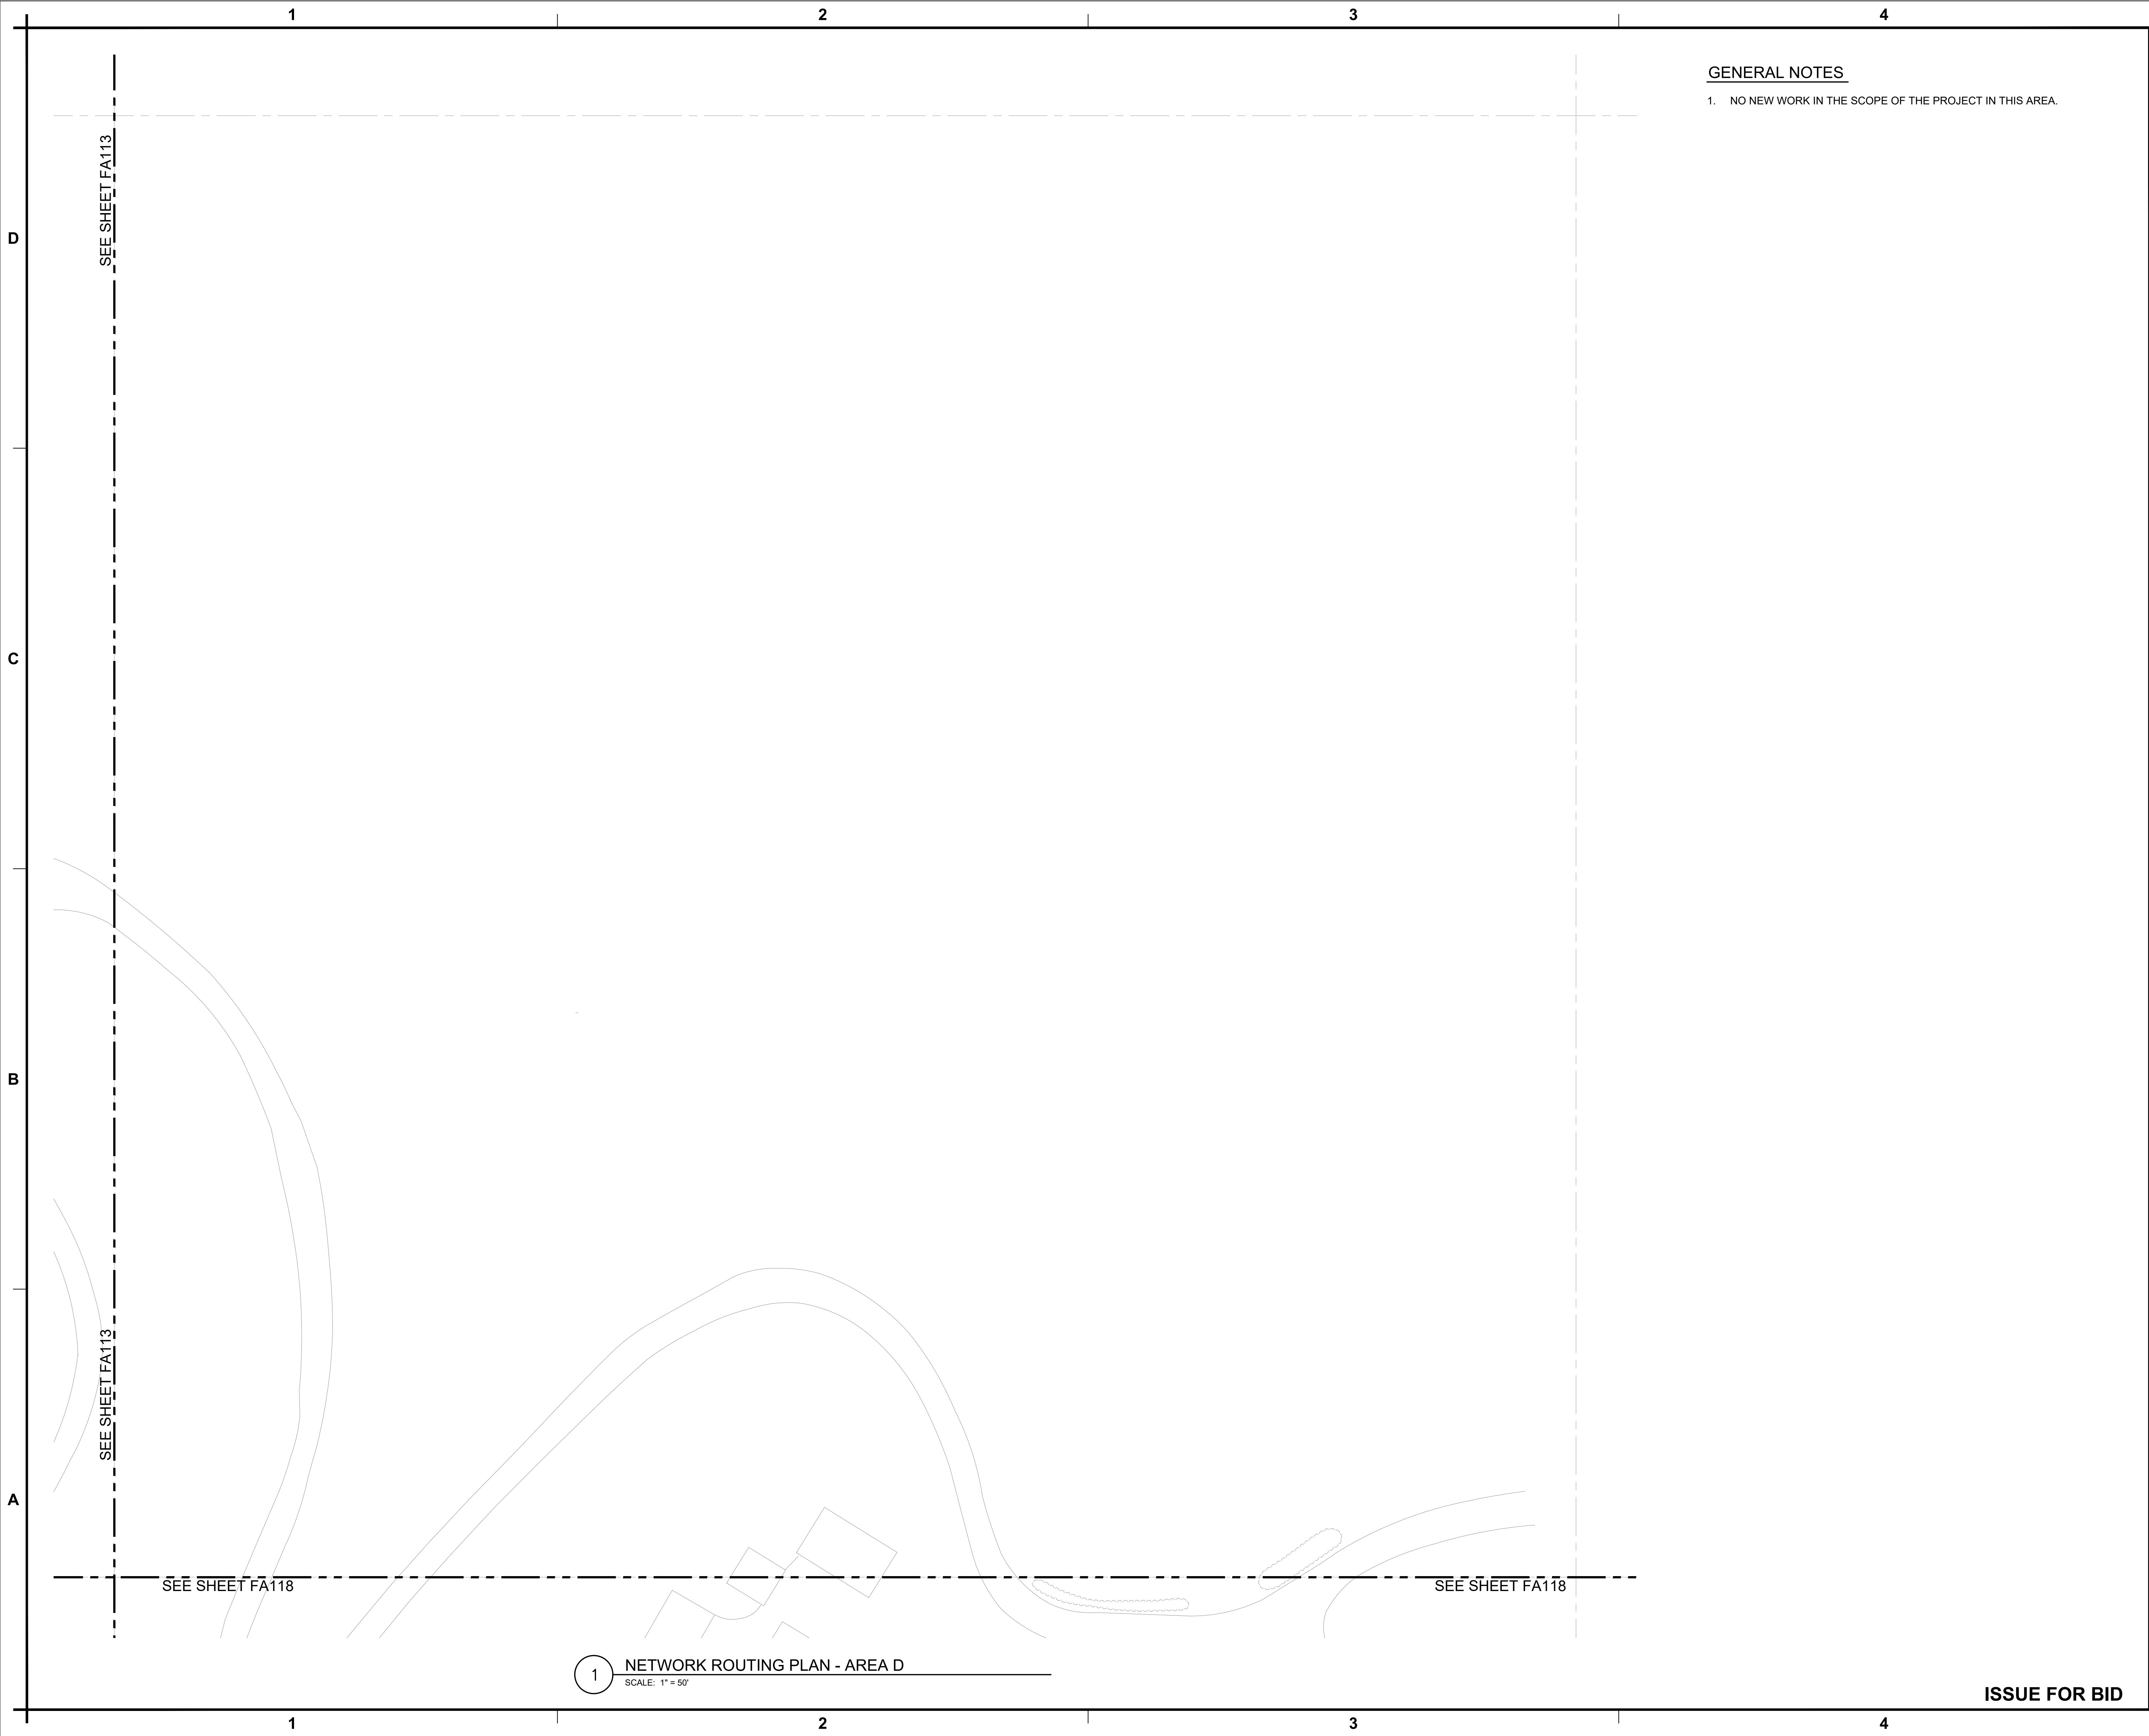


GENERAL NOTES
1. NO NEW WORK IN THE SCOPE OF THE PROJECT IN THIS AREA.

MARYLAND ZOO

JENSEN HUGHES
Advancing the Science of Safety
3610 Commerce Drive
Suite 817
Baltimore, MD 21227-1640
O: 410-737-8577 | F: 410-737-8588
www.jensenhughes.com

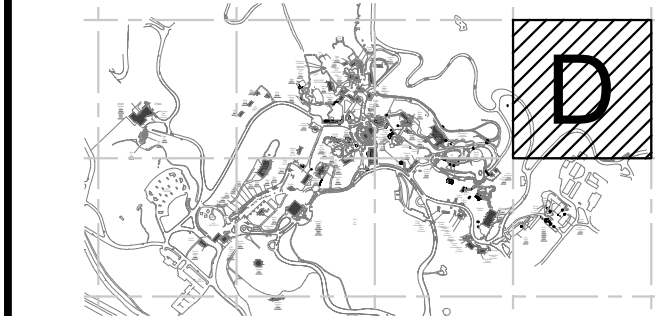

No.	Revision	Date

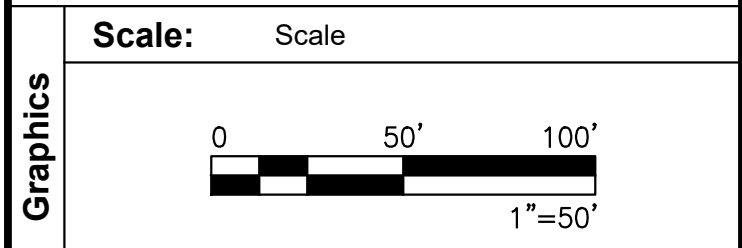


Project Description	FIRE ALARM MONITORING NETWORK REPLACEMENT CONCEPTUAL DESIGN
	Location: 1876 Mansion House Drive Baltimore, MD 21217
	Design: GM
	Drawn: DG
	Review: WW
Design	Date: FEBRUARY 15, 2022


Drawing Title
**NETWORK ROUTING
PLAN - AREA D**

Drawing No.
FA114

Sheet: 16 of 21

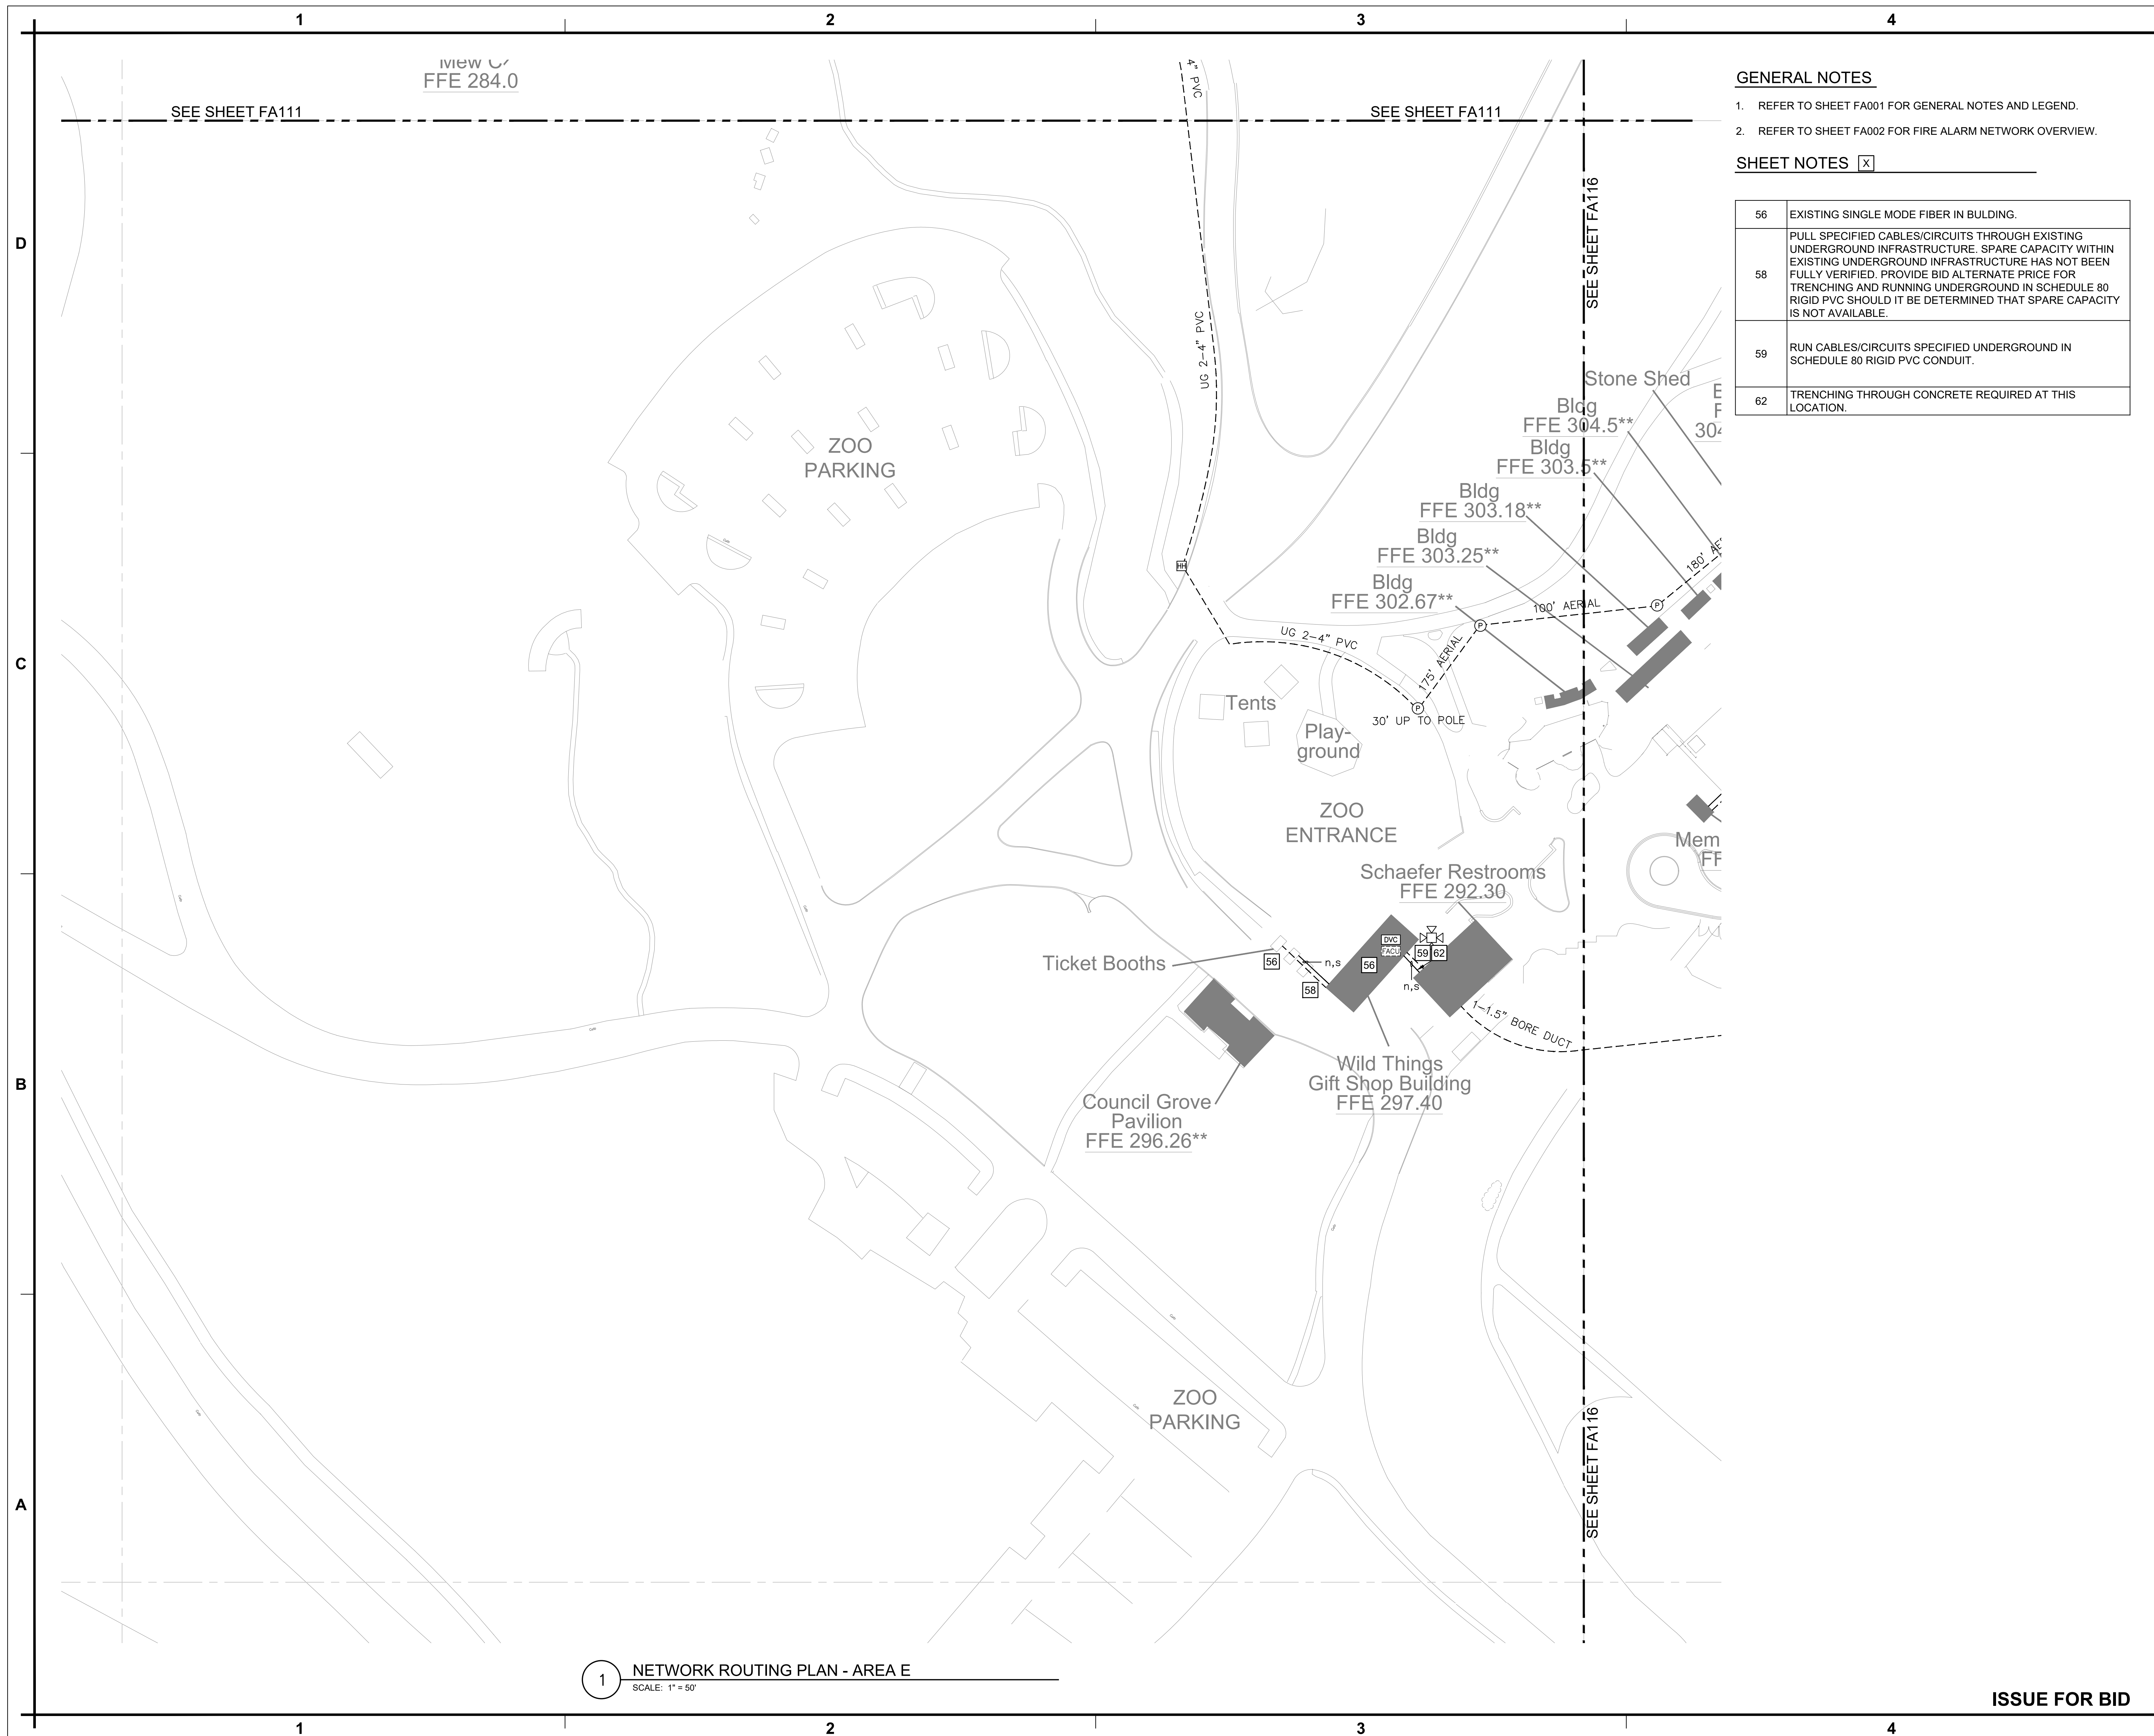

MARYLAND ZOO

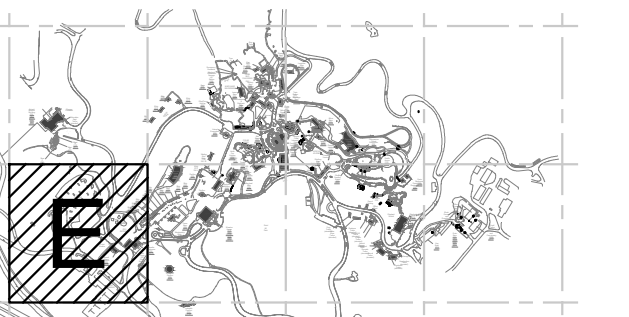[illegible]

Graphics	Scale: Scale
	A graphic scale bar with markings at 0, 50', and 100'. Below the bar, it indicates 1"=50'.


Project Description	FIRE ALARM MONITORING NETWORK REPLACEMENT CONCEPTUAL DESIGN
---------------------	--

Design	Project	Location:	1876 Mansion House Drive Baltimore, MD 21217
		Design:	GM
		Drawn:	DG
		Review:	WW
		Date:	FEBRUARY 15, 2022

**NETWORK ROUTING
PLAN - AREA E**

FA115

Sheet: 17 of 21

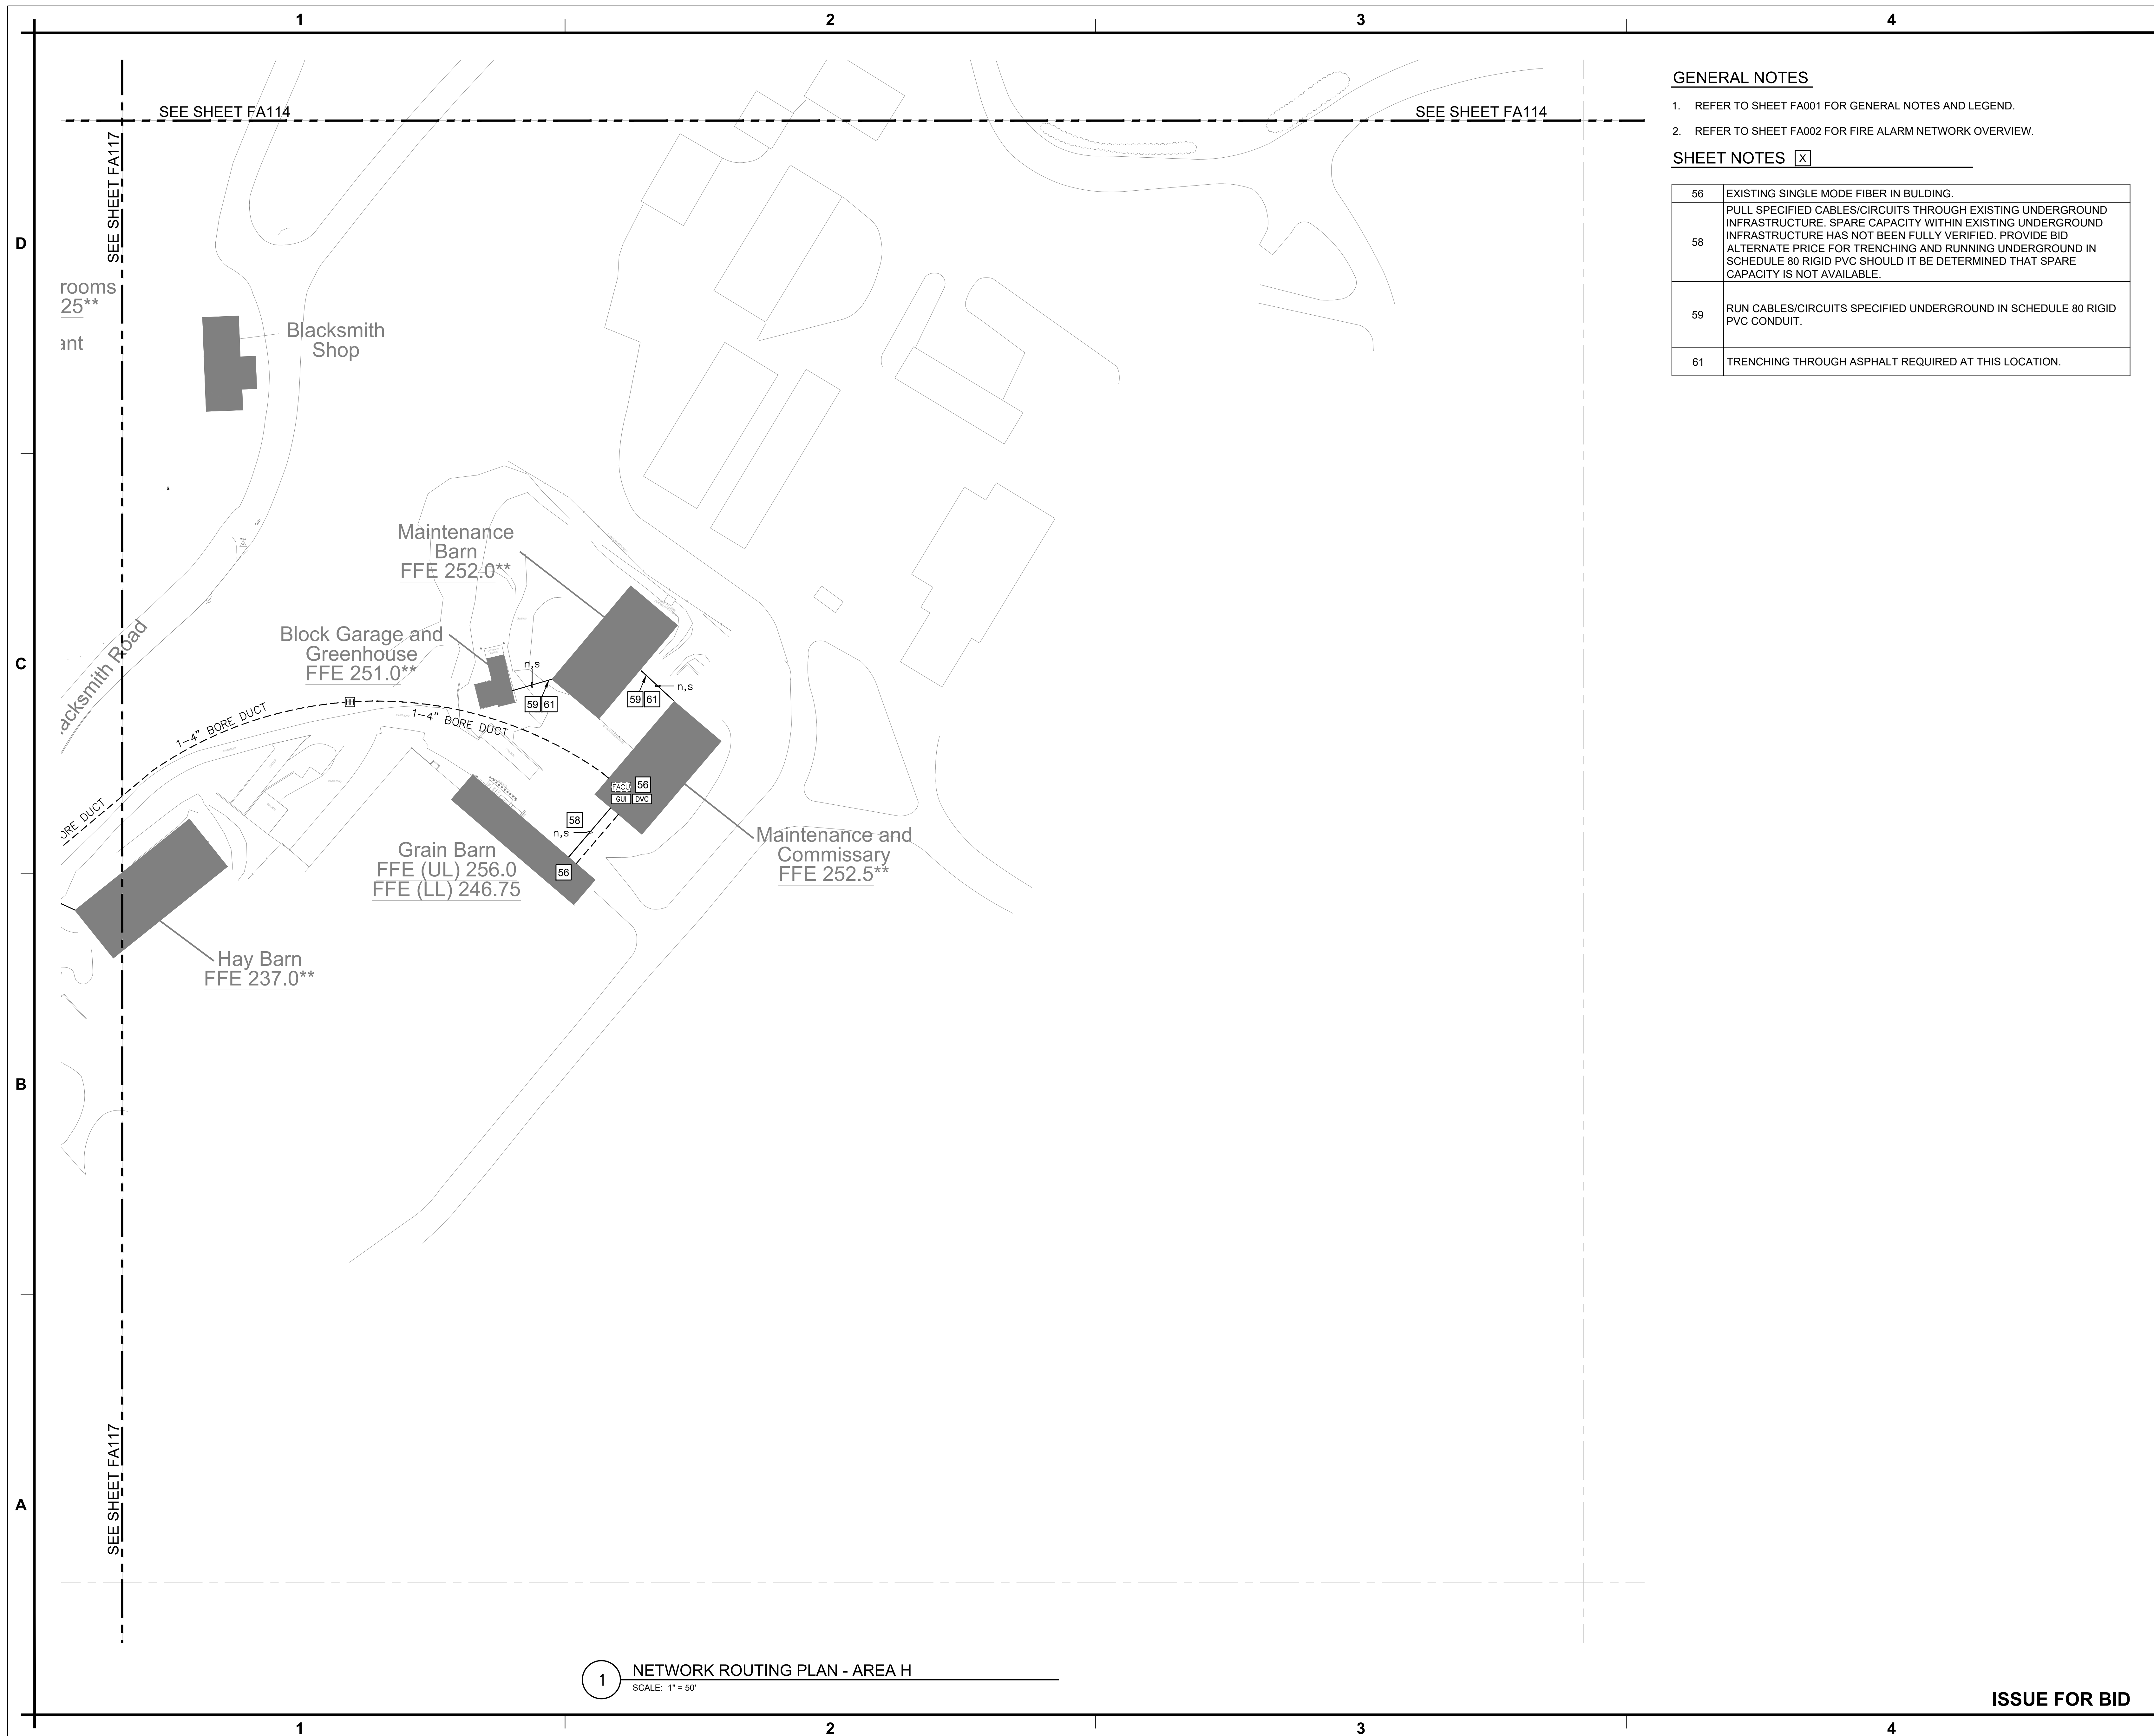

MARYLAND ZOO

[illegible]

Graphics	Scale: Scale
	A graphic scale bar with three segments. The first segment is black and labeled '0'. The second segment is white and labeled '50\''. The third segment is black and labeled '100\''. Below the bar, it says '1"=50\''.

Project Description	FIRE ALARM MONITORING NETWORK REPLACEMENT CONCEPTUAL DESIGN

Proj	Location: 1876 Mansion House Drive Baltimore, MD 21217

Design	Design:	GM
	Drawn:	DG
	Review:	WW


	Date: FEBRUARY 15, 2022
Title	

NETWORK ROUTING PLAN - AREA H

Drawing No.	FA118
Drawn by	

Drawn	
	Sheet: 20 of 21

ISSUE FOR BID

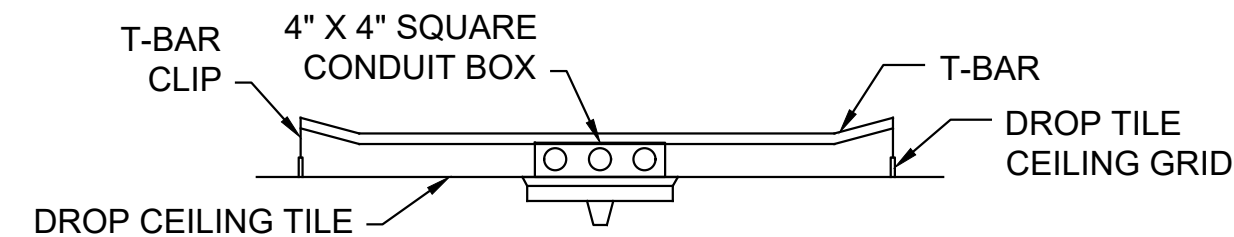

A diagram showing the installation of the Title Bridge. A rectangular panel, labeled "TITLE BRIDGE (INSTALL ON TOP OF SUSPENDED CEILING)", is shown being placed over a circular opening in a ceiling. Below the ceiling, a circular component labeled "SPEAKER/HORN" is visible, connected to the bridge by a vertical line. A label "BACKBOX" points to the top of the circular opening in the ceiling.

PAINT CONDUIT TO MATCH ADJACENT SURFACE

SMOOTH BACKBOX WITH NO KNOCKOUTS.
PAINT TO MATCH DEVICE.

STROBE

SPEAKER/HORN

7-50 A.F.F.

Diagram illustrating the installation of an octagon conduit back box into a drop ceiling tile. The back box is secured by T-bar clips, which are attached to the drop ceiling grid. The drop ceiling tile is shown being lowered into place.

The diagram illustrates the correct and incorrect ways to install a return air duct. It shows a cross-section of a wall with a duct passing through it. The duct has a rubber plug at the exterior end and a return grille at the interior end. Arrows indicate the direction of airflow from the room into the duct.

- Top Section (Incorrect):** Labeled "TUBE SUPPORT HOLE THROUGH OPPOSITE SIDE ONLY FOR DUCTS MORE THAN 3FT (0.9 M) WID". It shows a duct with a rubber plug on the exterior side and a return grille on the interior side. Arrows indicate "AIRFLOW" and "DIRECTION" from the room into the duct.
- Bottom Section (Correct):** Labeled "DO NOT INSERT RUBBER PLUG". It shows a duct with a return grille on the exterior side and a return grille on the interior side. Arrows indicate "EXPECTED AIRFLOW DIRECTION" from the room into the duct.
- Labels:**
 - "INLET TUBE HOLES FACE UPSTREAM OF AIRFLOW" (pointing to the exterior grille in the correct configuration)
 - "RETURN TUBE SLANT CUT FACE ORIENTED DOWNSTREAM OF AIRFLOW" (pointing to the interior grille in the correct configuration)

The diagram illustrates the installation of a fire alarm system in a room. Key components and requirements shown include:

- Ceiling Mounted Smoke/Heat Detector:** Located on the ceiling, with a label pointing to it.
- A/C Supply Diffuser:** Located on the ceiling, with a label pointing to it.
- Ceiling:** The top surface of the room, indicated by a hatched line.
- Audio/Visual and Visual-Only Devices:** Two circular devices mounted on the wall, with a label pointing to them.
- Synchronize More Than Two Appliances in Any Field of View:** A note indicating that the devices should be synchronized.
- At Least 6-Inch Below Ceiling:** A dimension line indicating the minimum clearance between the ceiling and the devices.
- Manual Pull Station:** A rectangular device mounted on the wall, with a label pointing to it.
- 5-Foot:** A dimension line indicating the distance between the manual pull station and the ceiling.
- 80-Inch Min. 96-Inch Max.:** A dimension line indicating the height of the manual pull station from the floor.
- 42 to 48-Inch:** A dimension line indicating the height of the manual pull station from the floor.
- Finished Floor:** The bottom surface of the room, indicated by a hatched line.
- Finished Wall:** The wall where the devices are mounted, indicated by a hatched line.
- Side Wall:** The wall on the right side of the room, indicated by a hatched line.

ISSUE FOR BID

[illegible]

Scale:	AS NOTED
---------------	----------

Project Description	FIRE ALARM MONITORING NETWORK REPLACEMENT CONCEPTUAL DESIGN
---------------------	--

Proj	Location: 1876 Mansion House Drive Baltimore, MD 21217

Design:	GM
---------	----

gn	Deorigin:	...
	Drawn:	DG

Design:	Drawn: WW
	Review: WW
	Date: FEBRUARY 15, 2022

Living Title	DETAILS
--------------	---------

Draw	
------	--

FA500

Sheet: 12 of 21